


Note: This drawing shows the typical layout and listing of equipment in this unit. Please verify the current layout and equipment specifications with your Stewart's Mobile Concepts Representative.

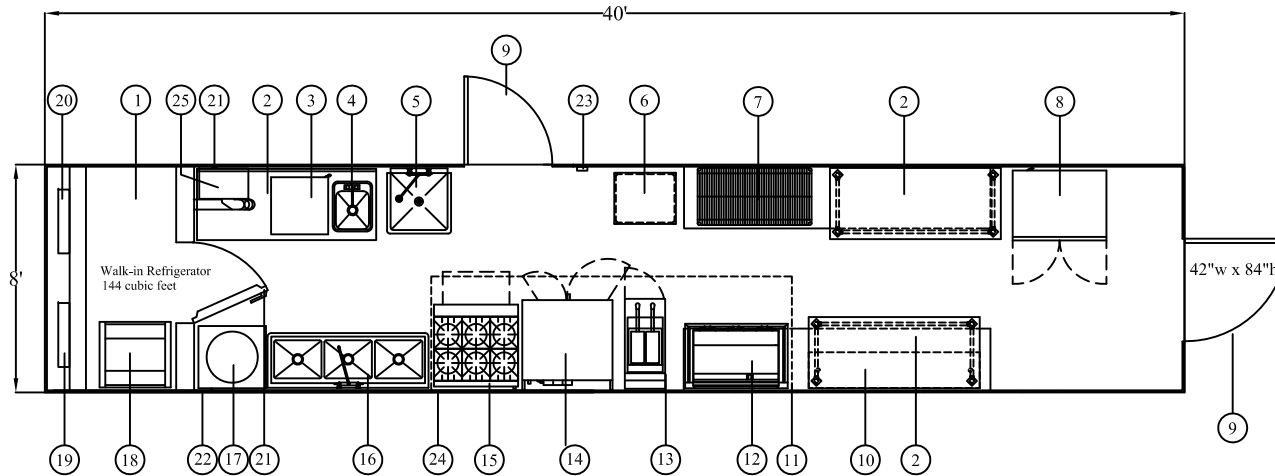

Floor Plan

Equipment List


- | | |
|---|---|
| <ul style="list-style-type: none"> 1. Walk-In Refrigerator 2. S/S Preparation Table 3. Commercial Dish Washer(Single Rack Under Counter) 4. S/S Hand Washing Sink 5. Large S/S Pot Sink W/ Pot Sprayer Faucet 6. S/S Prep Table 7. Metro Storage Cage 8. Double Door Upright Refrigerator 9. Entry Door W/ Closer 10. S/S Wall Shelf 11. S/S Exhaust Hood W/ Ansul Fire Suppression System 12. 36" Flat Top Griddle | <ul style="list-style-type: none"> 13. Double Basket Fryer 14. 2 Convection Ovens (Double Stack) 15. 6 Burner Stove W/ Oven Underneath 16. 3 Compartment Sink W/ Hot and Cold Water 17. 40 Gal Hot Water Heater 18. Upright Sheet Pan Rack (inside walk-in) 19. Electrical Panel 220v / 1 Phase / 130 Amp 20. Propane Connection 21. Walk-in Door 22. 3/4" Fresh Water Connection Location 23. Ansul Pull Station 24. 2" Waste Water Connection 25. Overhead Heater Furnace Unit |
|---|---|

Note: Trailer Power Requirements

220v / 1 Phase / 130A

Not Shown:

 - * Chest Freezer
- * Air Conditioning Unit (Exterior Installed)
- * K-type Fire Extinguisher
- * Extra 120v outlets throughout



THIS PRINT IS THE PROPERTY OF STEWART'S MOBILE CONCEPTS, LTD AND REPRESENTS A PROPRIETARY ARTICLE IN WHICH STEWART'S MOBILE CONCEPTS, LTD, RETAINS ANY AND ALL PATENT AND OTHER RIGHTS, INCLUDING EXCLUSIVE RIGHTS OF USE AND/OR MANUFACTURE, AND/OR SALE. POSSESSION OF THIS PRINT DOES NOT CONVEY ANY PERMISSION TO REPRODUCE PRINT OR MANUFACTURE ARTICLE(S) SHOWN HEREIN, SUCH PERMISSION TO BE GRANTED ONLY BY SPECIFIC AUTHORIZATION IN WRITING, SIGNED BY AN OFFICER OR OTHER AUTHORIZED AGENT OF STEWART'S MOBILE CONCEPTS, LTD, THEREOF. SPECIFICATION CANNOT BE CHANGED WITHOUT WRITTEN APPROVAL OF STEWART'S MOBILE CONCEPTS, LTD.

REV	DATE	BY	CHK	ECM #	DESCRIPTION
STEWART'S MOBILE CONCEPTS, LTD. 845 EAST JERICHO TURNPIKE Huntington Station, New York 11746					
TITLE: K-100 Overhead View					
MODEL: K 100 Hot Kitchen					
PATH: D:\Mobile Kitchens\K100					PART NO.:
SCALE: NTS	PLOTS/SCALE: 1	DATE: 04-10-09	DRAWING NO.:		
DRAWN BY: RDC	LAST UPDATED: 12/13/09		K-100		