



**Note:** This drawing shows the typical layout and listing of equipment in this unit. Please verify the current layout and equipment specifications with your Stewart's Mobile Concepts Representative.

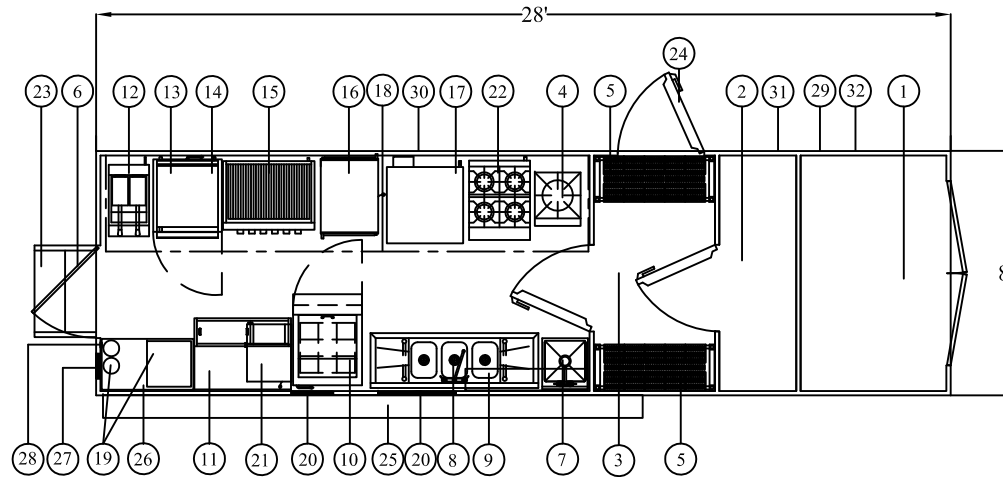

**Floor Plan**

 **Equipment List**

- |  |   |   |
|--|---|---|
| 1. Lockable Generator Equipment Compartment            | 11. Ice Bin W/ Exterior Service 4 Flavor Soda & Ice dispenser | 22. 4-Burner Range W/ Standard Oven & Pot Filler Faucet |
| 2. Reach-in Freezer 6'10" w x 2'5" d X 3'8" h          | 12. Double Basket Floor Model Fryer                           | 23. Exterior mounted Entry Steps                        |
| 3. Walk-in Refrigerator 6'10" w x 4' d X 7'1" h        | 13. 24" Countertop Griddle                                    | 24. Delivery Hatch to Walk-in Refrigerator              |
| 4. Stock Pot Burner                                    | 14. Under-counter Reach-in Refrigerator                       | 25. 16' Retractable Canopy                              |
| 5. S/S 4-tier Storage Shelves                          | 15. 36" Char Broiler W/ Storage Base                          | 26. S/S Work Top 36" x 21" w                            |
| 6. Entry Door W/ Screen                                | 16. Under Counter Hot Holding Cabinet                         | 27. Electrical Panel Exterior Recessed                  |
| 7. S/S Hand Sink                                       | 17. 1/2 Size Dual Stack Convection Ovens                      | 28. Ansul Pull Station                                  |
| 8. S/S 3 Compartment Sink W/ S/S Fold Down Countertops | 18. S/S Exhaust Hood W/ Ansul Fire Suppression System         | 29. 3/4" Fresh Water Hook-up To Standard Hose           |
| 9. S/S Over-Shelf W/ Marine Rail                       | 19. Post Mix Soda & Carbonator Location                       | 30. Waste Water 3" Dump Valve Location                  |
| 10. Reach-in Refrigerator W/ Sandwich Making Prep-Top  | 20. Pass Thru Service Window                                  | 31. LP Vapor Propane Tie-in Location                    |
|  | 21. Conveyor Toaster W/ Wall Shelf                            | 32. Electrical Tie-in Location                          |



**Items Not Shown**

- |  |   |
|--|---|
| 1. 2 RV Style Air-conditioning Units           | 6. 20kv Generator On Board              |
| 2. Extra 110v Convenience Outlets              | 7. 50' Cable for Shore Power Connection |
| 3. Hot Water Heater                            | 8. Fire Extinguisher (Wall Mounted)     |
| 4. Remote Refrigeration Compressor             | 9. Fresh Water Holding Tanks            |
| 5. Transfer Switch for Generator & Shore Power | 10. Waste Water Holding Tanks           |

**Note:** Trailer Power Requirements:  
208v/ 1 Phase/ 100 A

THIS PRINT IS THE PROPERTY OF STEWART'S MOBILE CONCEPTS, LTD. AND REPRESENTS A PROPRIETARY ARTICLE IN WHICH STEWART'S MOBILE CONCEPTS, LTD. RETAINS ANY AND ALL PATENT AND OTHER RIGHTS, INCLUDING EXCLUSIVE RIGHTS OF USE AND/OR MANUFACTURE, AND/OR SALE. POSSESSION OF THIS PRINT DOES NOT CONVEY ANY PERMISSION TO REPRODUCE, PRINT OR MANUFACTURE ARTICLES(S) SHOWN HEREIN, SUCH PERMISSION TO BE GRANTED ONLY BY SPECIFIC AUTHORIZATION IN WRITING, SIGNED BY AN OFFICER OR OTHER AUTHORIZED AGENT OF STEWART'S MOBILE CONCEPTS, LTD. THEREOF. SPECIFICATION CANNOT BE CHANGED WITHOUT WRITTEN APPROVAL OF STEWART'S MOBILE CONCEPTS, LTD.

REV	DATE	BY	CHK	ECN #	DESCRIPTION
<b>STEWART'S MOBILE CONCEPTS, LTD.</b> 845 EAST JERICO TURNPIKE Huntington Station, New York 11746					
TITLE:		K-128 Overhead View			
MODEL:		K-128 Hot Kitchen			
PATH: D:\Acad\StewartsMobile\K 128					PART NO.:
SCALE: NTS	PLOTS/SCALE: 1	DATE: 06/15/09	DRAWING NO.:		
DRAWN BY: RDC		LAST UPDATED: 08/30/09	K-128		