


**Note:** This drawing shows the typical layout and listing of equipment in this unit. Please verify the current layout and equipment specifications with your Stewart's Mobile Concepts Representative.

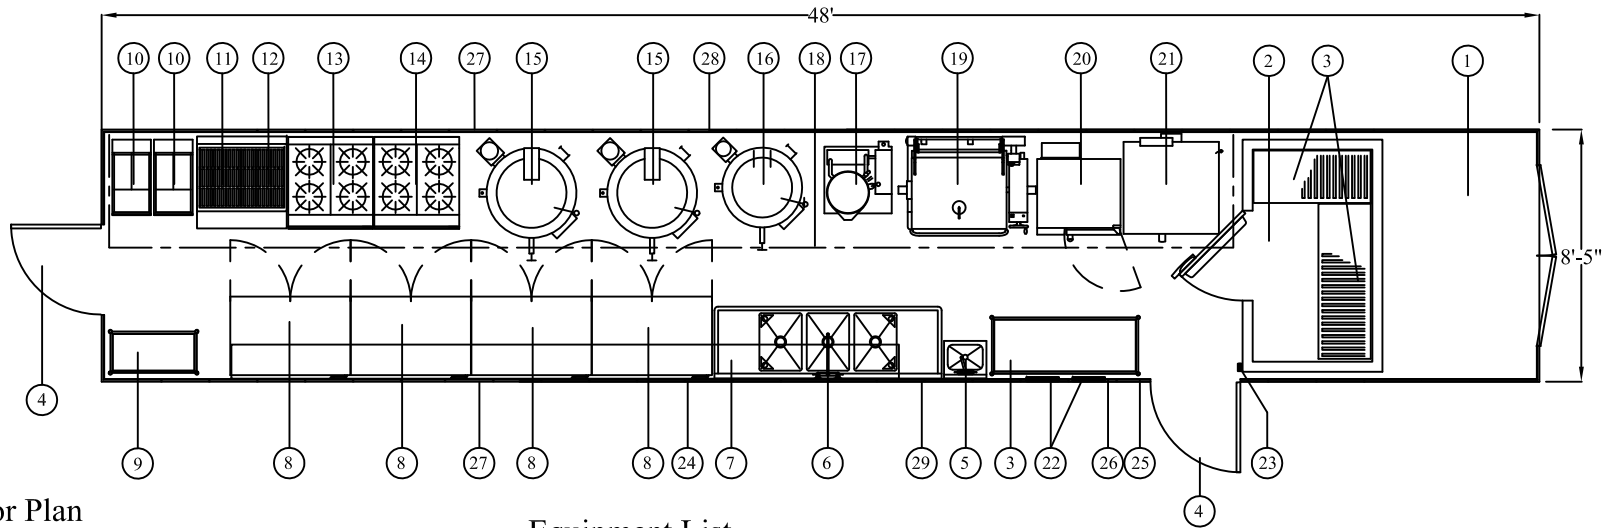


Floor Plan

**Equipment List**

 - |  |   |   |  |
|--|---|---|--|
| 1. lockable Generator Equipment Room                       | 9. S/S 4 Tier Shelving 36" Wide             | 17. 10 Gal. Steam Kettle W/ Stand                     | 24. 3/4" Fresh Water Hook-up to Standard Hose    |
| 2. Walk-in Refrigerator 7' w x 4' d x 7'3" h               | 10. Double Basket Floor Model Fryer         | 18. S/S Exhaust Hood W/ Ansul Fire Suppression System | 25. 3" Waste Water Tie-in Location               |
| 3. S/S 4 Tier Storage Shelving                             | 11. 36" Countertop Charbroiler              | 19. 40 Gal. Tilting Skillet                           | 26. Electrical Tie-in Location                   |
| 4. Entry Door W/ Closer                                    | 12. Storage Base for Charbroiler            | 20. Half Size Combination Oven                        | 27. Propane tanks                                |
| 5. S/S Hand Sink   | 13. 4 Burner Range W/ Convection Oven Below | 21. Dual Stack Convection Ovens                       | 28. Exterior Storage Compartments                |
| 6. S/S 3 Compartment Pot Sink W/ S/S Fold Down Counter Top | 14. 4 Burner Range W/ Standard Oven Below   | 22. Electrical Panels (Exterior Recessed)             | 29. Waste Water Holding Tanks With 3" Dump Valve |
| 7. S/S Over Shelf W/ Marine Rail                           | 15. 60 Gal. Steam Kettle                    | 23. Ansul Pull Station                                |  |
| 8. 2 Door Under Counter Refrigerator W/ S/S Counter Top    | 16. 40 Gal. Steam Kettle                    |   |  |

**Items Not Shown**

- |                                       |  |
|---------------------------------------|--|
| 1. Central Air Conditioning / Heating | 5. 69kv Generator On Board in Generator Room |
| 2. Extra 110v Convenience Outlets     | 6. Fire Extinguisher (Wall Mounted)          |
| 3. 50 Gal. Hot Water Heater           | 7. Fresh Water Holding Tanks                 |
| 4. Remote Refrigeration Compressor    | 8. Exterior Diesel Fuel Tank for Generator   |



THIS PRINT IS THE PROPERTY OF STEWART'S MOBILE CONCEPTS, LTD. AND REPRESENTS A PROPRIETARY ARTICLE IN WHICH STEWART'S MOBILE CONCEPTS, LTD. RETAINS ANY AND ALL PATENT AND OTHER RIGHTS, INCLUDING EXCLUSIVE RIGHTS OF USE AND/OR MANUFACTURE, AND/OR SALE. PERMISSION TO BE GRANTED ONLY BY SPECIFIC AUTHORIZATION IN WRITING, SIGNED BY AN OFFICER OR OTHER AUTHORIZED AGENT OF STEWART'S MOBILE CONCEPTS, LTD. THEREOF. SPECIFICATION CANNOT BE CHANGED WITHOUT WRITTEN APPROVAL OF STEWART'S MOBILE CONCEPTS, LTD.

**Note:** Trailer Power Requirements:  
208v/ 3Phase /200 A

REV	DATE	BY	CK	ECN #	DESCRIPTION
<b>STEWART'S MOBILE CONCEPTS, LTD.</b> 845 EAST JERICHO TURNPIKE Huntington Station, New York 11746					
TITLE: <b>K-283 Overhead View</b>					
MODEL: <b>K-283 Hot Kitchen</b>					
PART: D:\Acad\StewartsMobile\K 283					PART NO.:
SCALE: NTS	PLOTS/SCALE: 1	DATE: 05/30/2009	DRAWING NO.:		
DRAWN BY: RDC	LAST UPDATED: 08/30/2009		<b>K-283</b>		