


**Note:** This drawing shows the typical layout and listing of equipment in this unit. Please verify the current layout and equipment specifications with your Stewart's Mobile Concepts Representative.

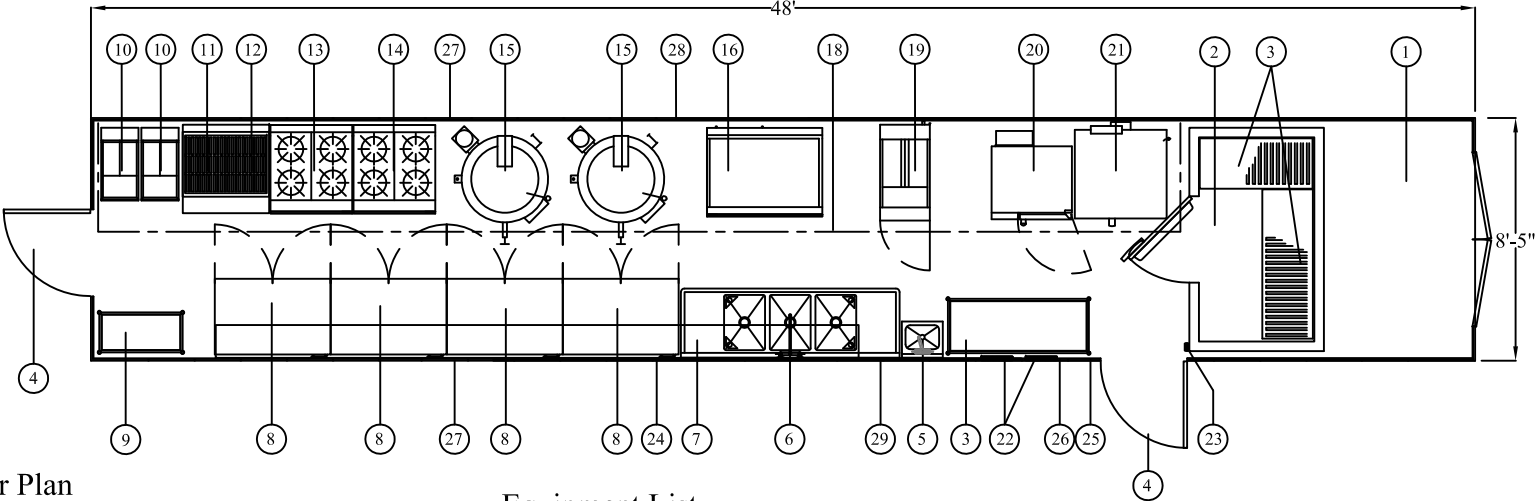


Floor Plan

**Equipment List**

 - |  |   |   |   |
|--|---|---|---|
| <ul style="list-style-type: none"> <li>1. lockable Generator Equipment Room</li> <li>2. Walk-in Refrigerator 7' w x 4' d x 7'3" h</li> <li>3. S/S 4 Tier Storage Shelving</li> <li>4. Entry Door W/ Closer</li> <li>5. S/S Hand Sink</li> <li>6. S/S 3 Compartment Pot Sink W/ S/S Fold Down Counter Top</li> <li>7. S/S Over Shelf W/ Marine Rail</li> <li>8. 2 Door Under Counter Refrigerator W/ S/S Counter Top</li> </ul> | <ul style="list-style-type: none"> <li>9. S/S 4 Tier Shelving 36" Wide</li> <li>10. Double Basket Floor Model Fryer</li> <li>11. 36" Countertop Charbroiler</li> <li>12. Storage Base for Charbroiler</li> <li>13. 4 Burner Range W/ Convection Oven Below</li> <li>14. 4 Burner Range W/ Standard Oven Below</li> <li>15. 60 Gal. Steam Kettle</li> <li>16. 48" Flat Top Griddle on Equipment Stand</li> </ul> | <ul style="list-style-type: none"> <li>17. Removed This Application</li> <li>18. S/S Exhaust Hood W/ Ansul Fire Suppression System</li> <li>19. 80 lb. Large Floor Model Fryer</li> <li>20. Half Size Combination Oven</li> <li>21. Dual Stack Convection Ovens</li> <li>22. Electrical Panels (Exterior Recessed)</li> <li>23. Ansul Pull Station</li> </ul> | <ul style="list-style-type: none"> <li>24. 3/4" Fresh Water Hook-up to Standard Hose</li> <li>25. 3" Waste Water Tie-in Location</li> <li>26. Electrical Tie-in Location</li> <li>27. Propane tanks</li> <li>28. Exterior Storage Compartments</li> <li>29. Waste Water Holding Tanks With 3" Dump Valve</li> </ul> |
|--|---|---|---|

**Items Not Shown**

- |   |   |
|---|---|
| <ul style="list-style-type: none"> <li>1. Central Air Conditioning / Heating</li> <li>2. Extra 110v Convenience Outlets</li> <li>3. 50 Gal. Hot Water Heater</li> <li>4. Remote Refrigeration Compressor</li> </ul> | <ul style="list-style-type: none"> <li>5. 69kv Generator On Board in Generator Room</li> <li>6. Fire Extinguisher (Wall Mounted)</li> <li>7. Fresh Water Holding Tanks</li> <li>8. Exterior Diesel Fuel Tank for Generator</li> </ul> |
|---|---|



A 162320/RC		Equipment Change	
REV	DATE	BY	DESCRIPTION
<b>STEWART'S MOBILE CONCEPTS, LTD.</b>			
845 EAST JERICHO TURNPIKE Huntington Station, New York 11746			
TITLE: <b>K-283 Overhead View</b>			
MODEL: <b>K-283 Hot Kitchen</b>			
PART NO:		PART NO:	
D:\Acad\Stewarts\Mobile\K 283			
SCALE: NTS	PLOTS/SCALE: 1	DATE: 05/30/2009	DRAWING NO.: K-283
DRAWN BY: RDC	LAST UPDATED: 08/30/2009		

THIS PRINT IS THE PROPERTY OF STEWART'S MOBILE CONCEPTS, LTD. AND REPRESENTS A PROPRIETARY ARTICLE IN WHICH STEWART'S MOBILE CONCEPTS, LTD. RETAINS ANY AND ALL PATENT AND OTHER RIGHTS, INCLUDING EXCLUSIVE RIGHTS OF USE AND/OR MANUFACTURE, AND/OR SALE. POSSESSION OF THIS PRINT DOES NOT CONVEY ANY PERMISSION TO REPRODUCE PRINT OR MANUFACTURE ARTICLE(S) SHOWN HEREIN, SUCH PERMISSION TO BE GRANTED ONLY BY SPECIFIC AUTHORIZATION IN WRITING, SIGNED BY AN OFFICER OR OTHER AUTHORIZED AGENT OF STEWART'S MOBILE CONCEPTS, LTD. THEREOF. SPECIFICATION CANNOT BE CHANGED WITHOUT WRITTEN APPROVAL OF STEWART'S MOBILE CONCEPTS, LTD.

**Note:** Trailer Power Requirements:  
208v/ 3Phase /200 A